

Revisions:				
Revision	Date	Revision Notes	Drawn	Inspected
01	31.10.24	First Issue	OB	JM
02	13.02.25	Updated Sub	OB	JM
03	17.04.25	Updated Sub	OB	JM
04	22.04.25	Dimensions Amended	OB	JM
05	28.04.25	Views Added	OM	JM

LEGEND:



MAIN TRANSFORMER
(23.28 X 14.91 X 10.00m)



ENERGY MANAGEMENT BUILDING
(24.98 X 16.74 X 7.29m)



SWITCHGEAR ROOM
(23.11 X 6.24 X 4.25m)



CONTROL & METERING ROOM
(14.00 X 4.98 X 6.25m)



EMERGENCY DIESEL GENERATOR
(4.37 X 1.6 X 3.5m)



COMMS & LV HOUSE
(12.18 X 5.63 X 6.25m)

LV TRANSFORMER
(2.15 X 1.62 X 2.30m)





COOLER
(11.68 X 2.40 X 2.68)




AIR CORE REACTOR
(1.8m DIA, 1.6m HIGH)



GENERATOR CIRCUIT BREAKER
(4.37 X 2.95 X 2.64)

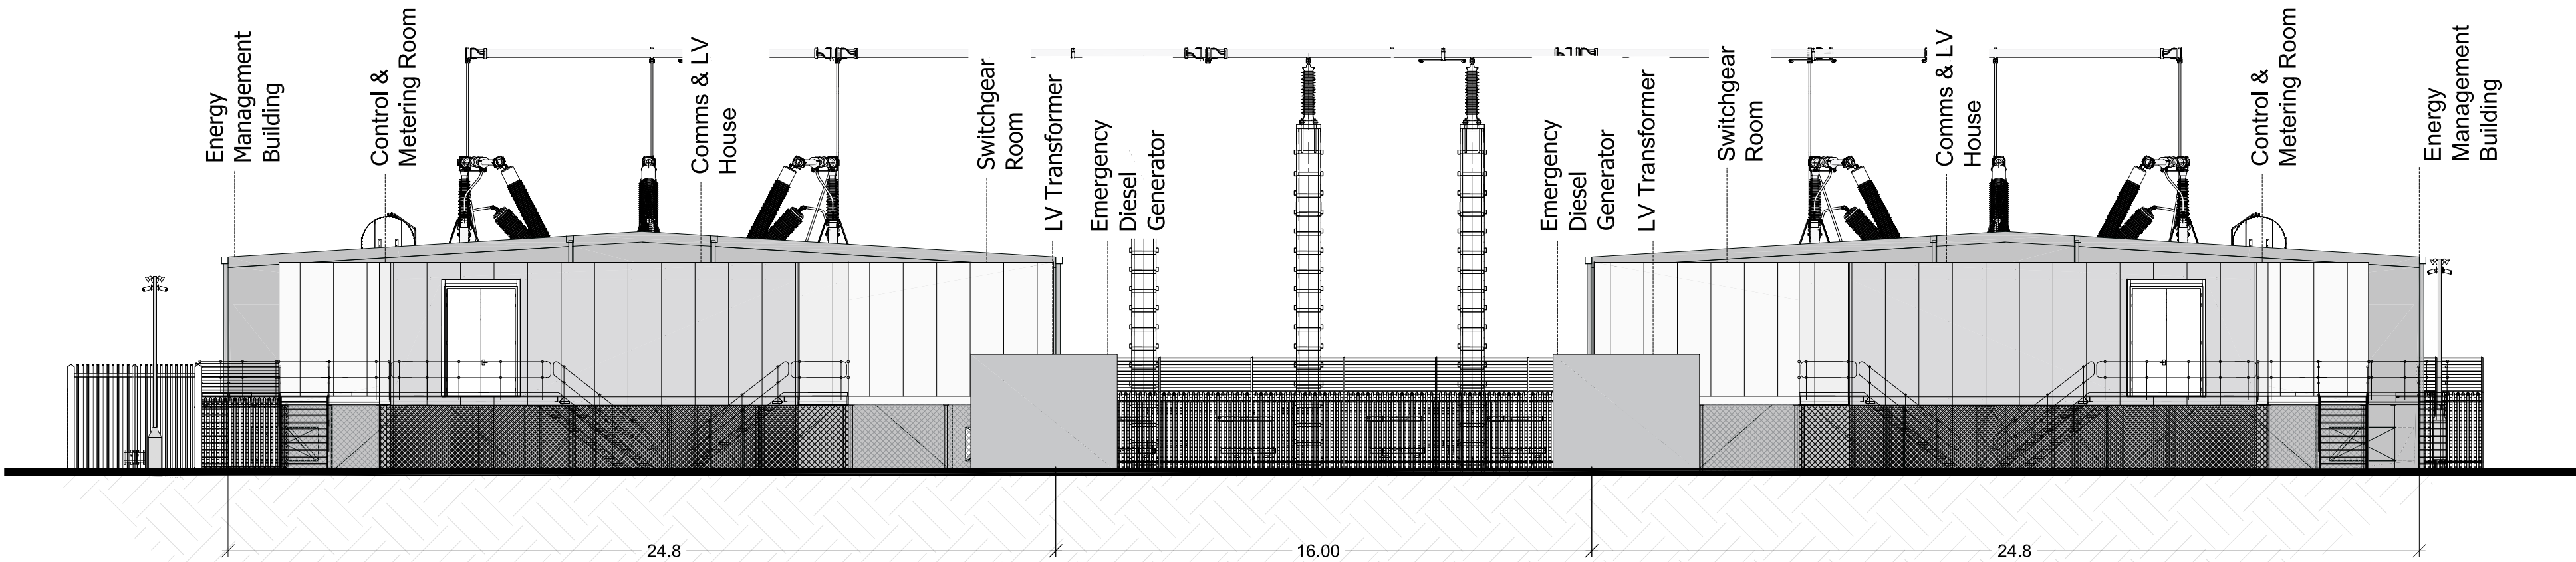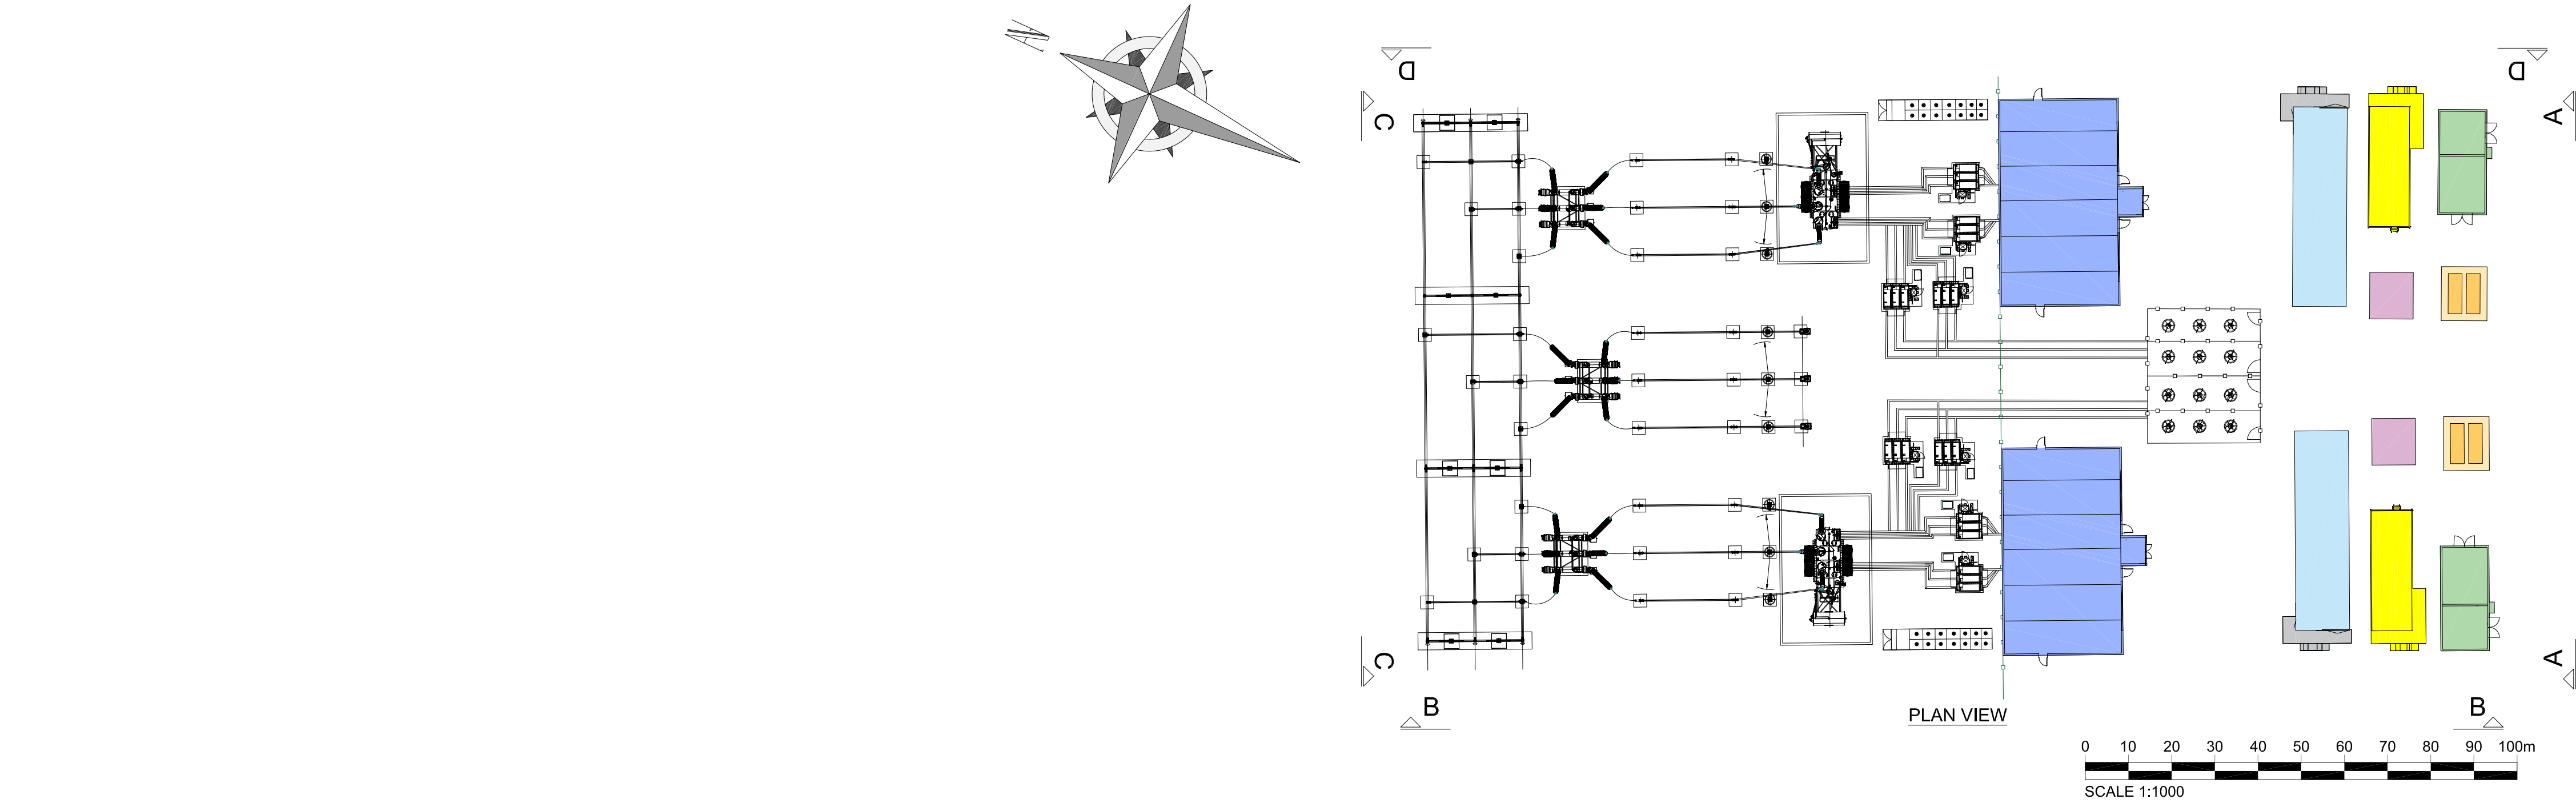

FRONT ELEVATION A-A

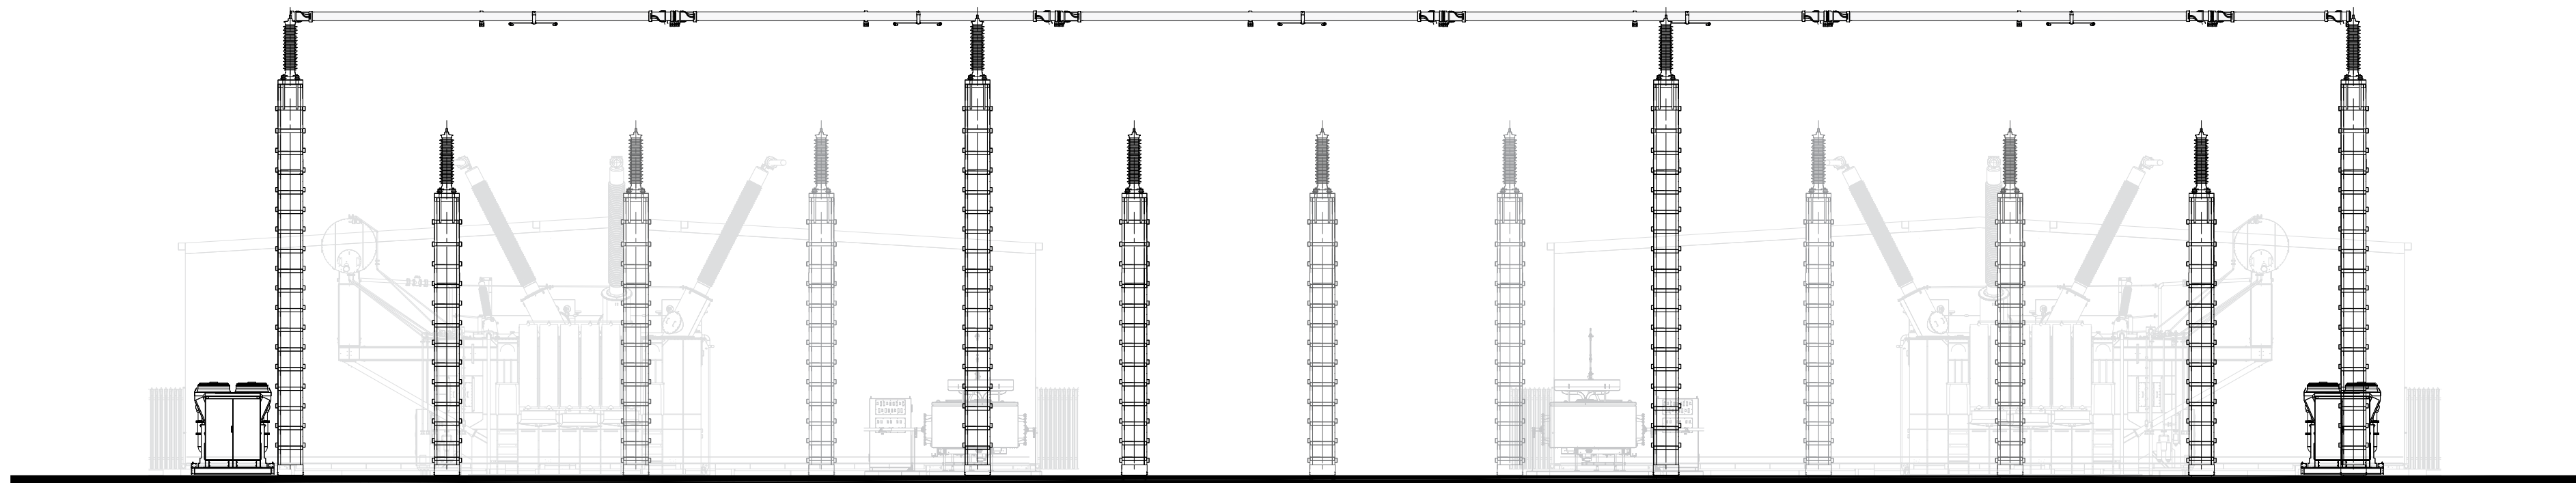

REAR ELEVATION C-C

Project:
East Claydon BESS Site

Consultant:



Statkraft UK Ltd.
19th Floor, 22 Bishopsgate
London, EC2N 4BG
Tel: +44 (0) 20 7549 1000

Drawn by:



CADmando
2D, 3D CAD & BIM SERVICES

CADmando Design & Draughting Solutions Ltd
Unit B2, The Courtyard, Severn Drive, Tewkesbury Business Park, GL20 8GD
Tel: +44 (0) 1684 850919
Mob: +44 (0) 7814439910

Status:
PLANNING

Drawing Title:
**Standard Details:
HV Yard**

Drawn: OB	Checked: JM	First Issued: 31.10.2024
--------------	----------------	-----------------------------

Project Code: **STA008-** Drawing Number: **SD-15**

Sheet Size: A3	Scale: A.N	Revision: 05
--------------------------	----------------------	------------------------